
 

Appendix 12.2.1C
Preliminary Design Drawings
(Water Quality and Liquid Discharges
Management Plan)

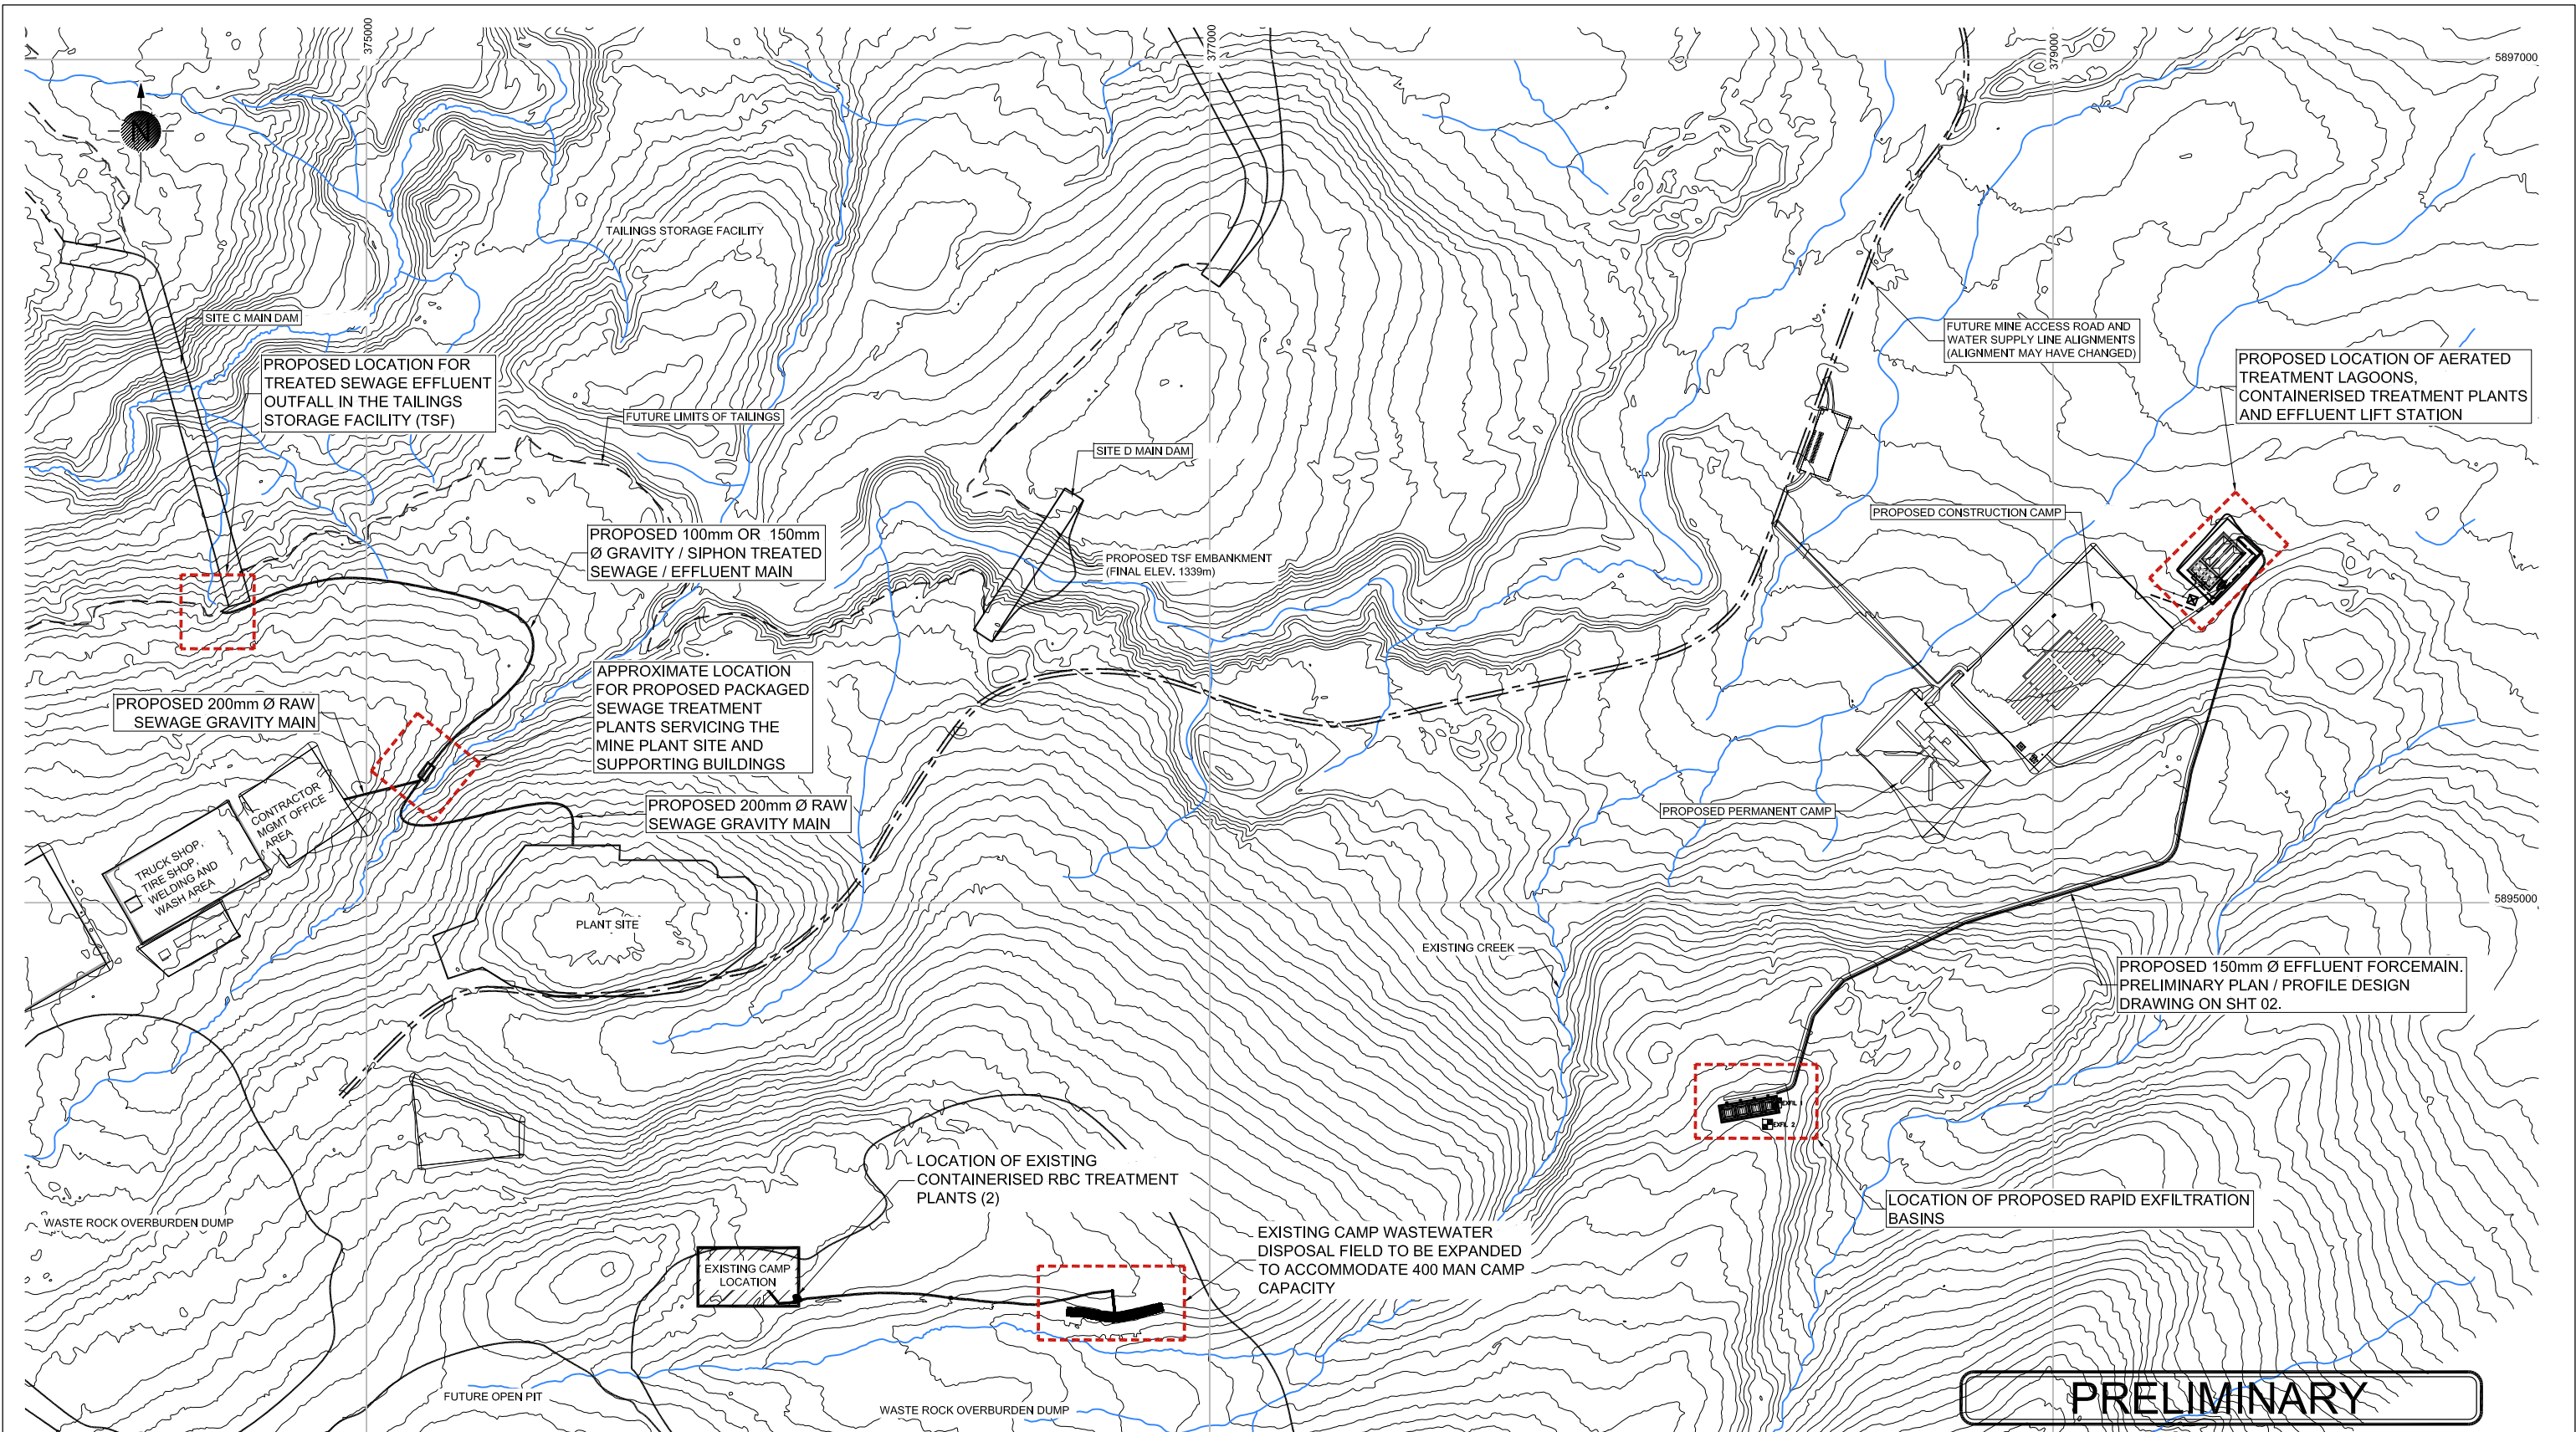

PRELIMINARY



| Revision | Amendment | Approved | Revision Date |
|----------|--------------------|----------|---------------|
| 1 | PRELIMINARY DESIGN | SRB | SEPT 2013 |
| | | | |
| | | | |
| | | | |

OPUS DAYTONKNIGHT
 Prince George Office
 201 - 1110 6TH AVENUE
 Prince George, BC
 V2L 3M6 CANADA +1 250 5620038




Project
**NEW GOLD INC.
 BLACKWATER PROJECT
 TEMPORARY AND PERMANENT CAMP WASTEWATER SYSTEM**

| Drawn | Designed | Approved | Revision Date |
|-------|----------|----------|---------------|
| LDHB | LDHB | SRB | |


Sheet
SITE PLAN

Project No. D-76002.00 Scale 1:7500

Drawing No. PG D-95002.00 Sheet No. 01 Revision 1

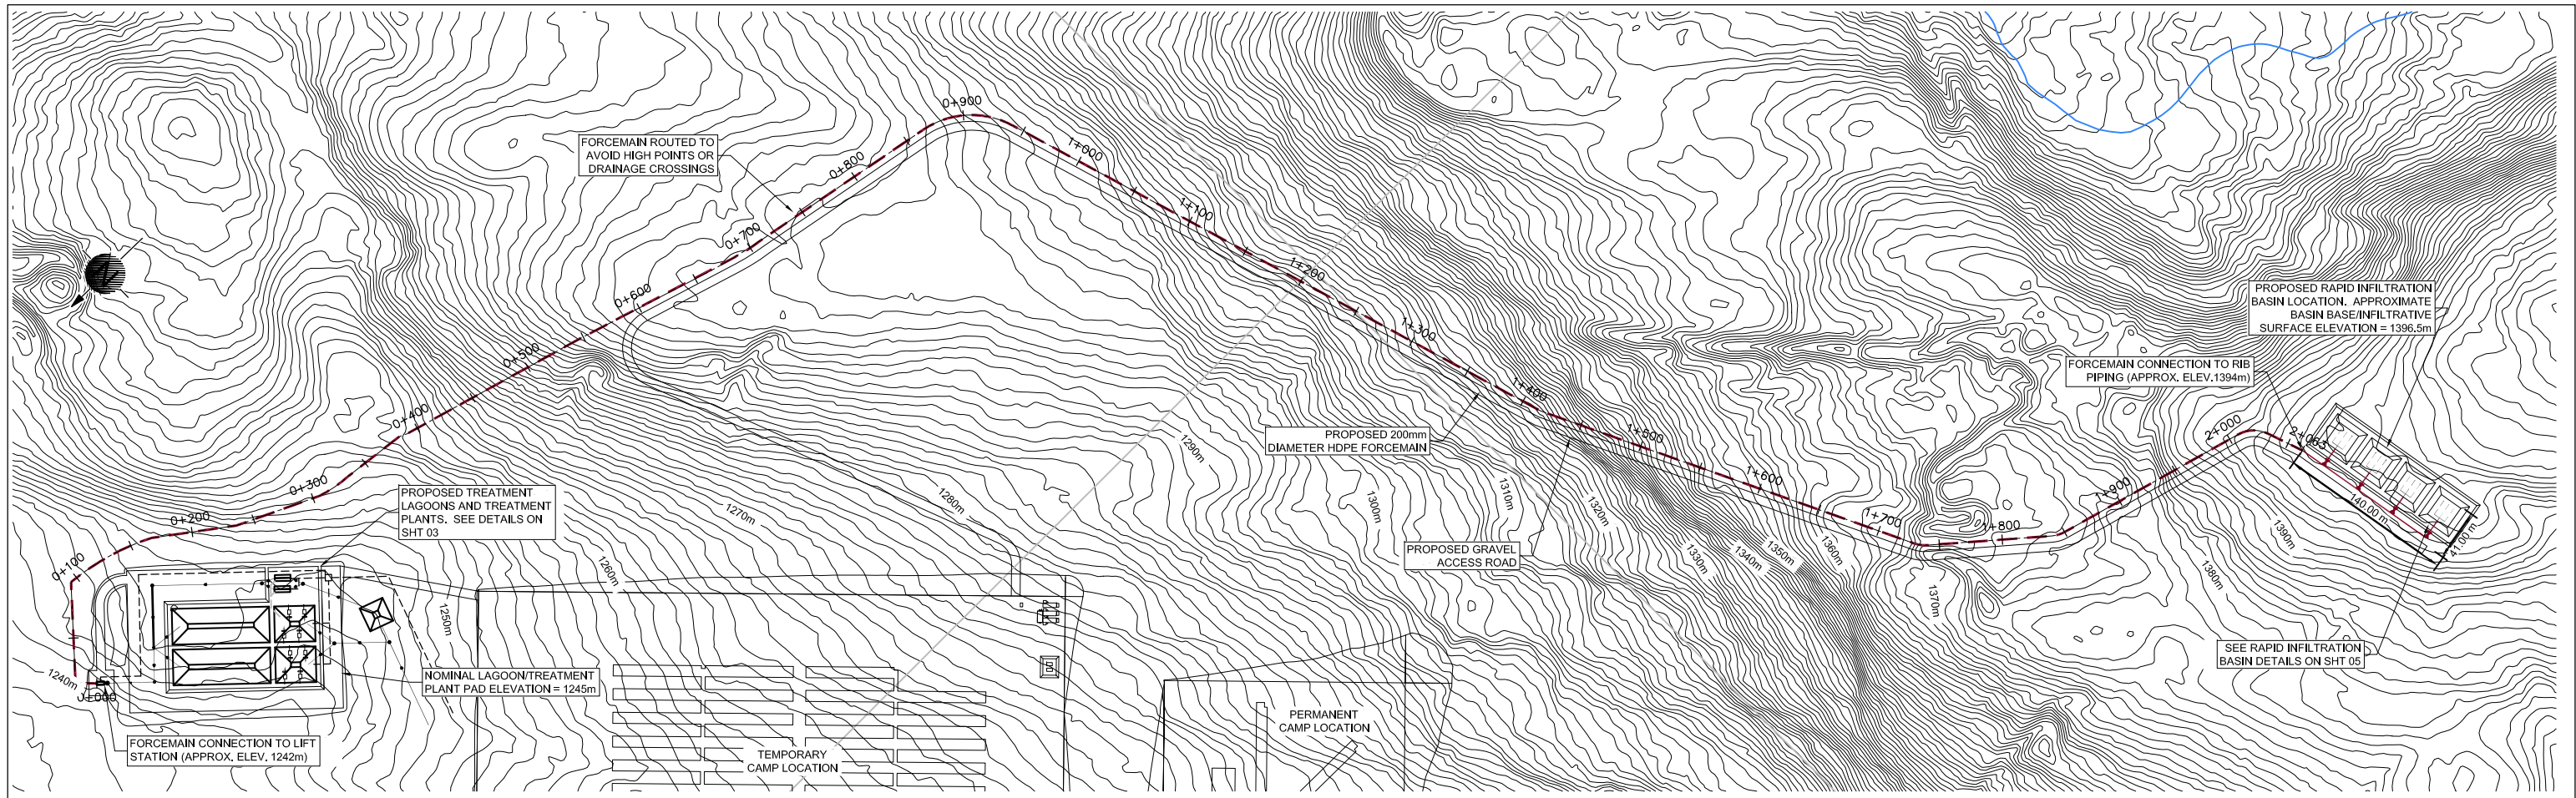

PLAN
1:5000

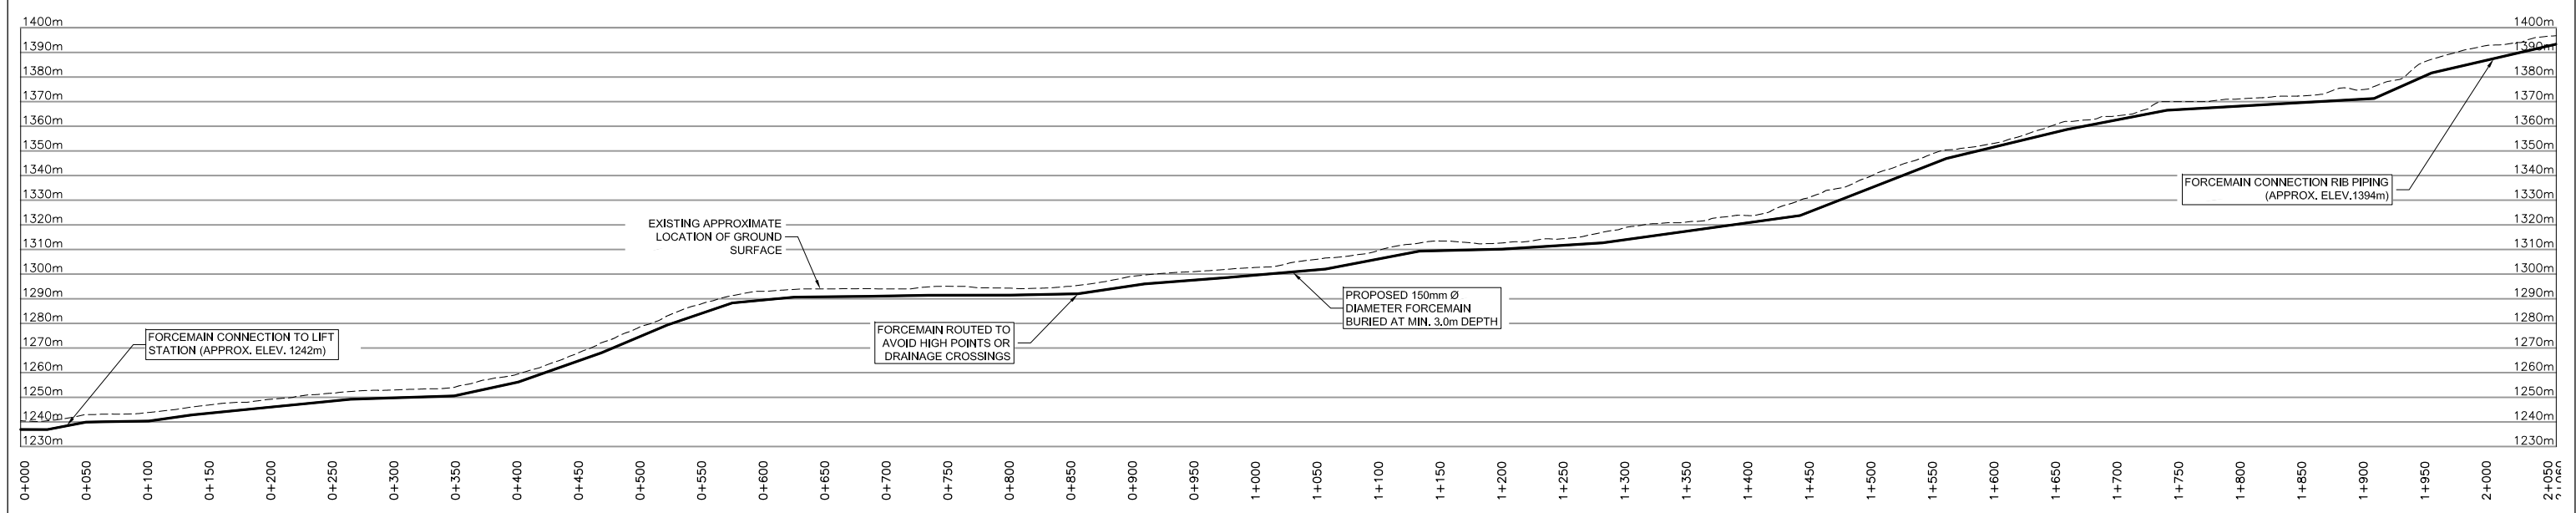

PROFILE
1:5000

PRELIMINARY

| Rev/Issn | Amendment | Approved | Revision Date |
|----------|--------------------|----------|---------------|
| 1 | PRELIMINARY DESIGN | SRB | SEPT 2013 |
| | | | |
| | | | |
| | | | |
| | | | |

OPUS DAYTONKNIGHT
 Prince George Office
 201 - 1110 6TH AVENUE
 Prince George, BC
 V2L 3M6 CANADA +1 250 5620038




Project
NEW GOLD INC.
BLACKWATER PROJECT
TEMPORARY AND PERMANENT CAMP WASTEWATER SYSTEM


Sheet
FORCEMAIN PLAN / PROFILE

| Drawn | Designed | Approved | Revision Date |
|-------|----------|----------|---------------|
| LDHB | LDHB | SRB | |

Project No. D-76002.00 Scale 1:7500

 Drawing No. PG D-95002.00 Sheet No. 02 Revision 1



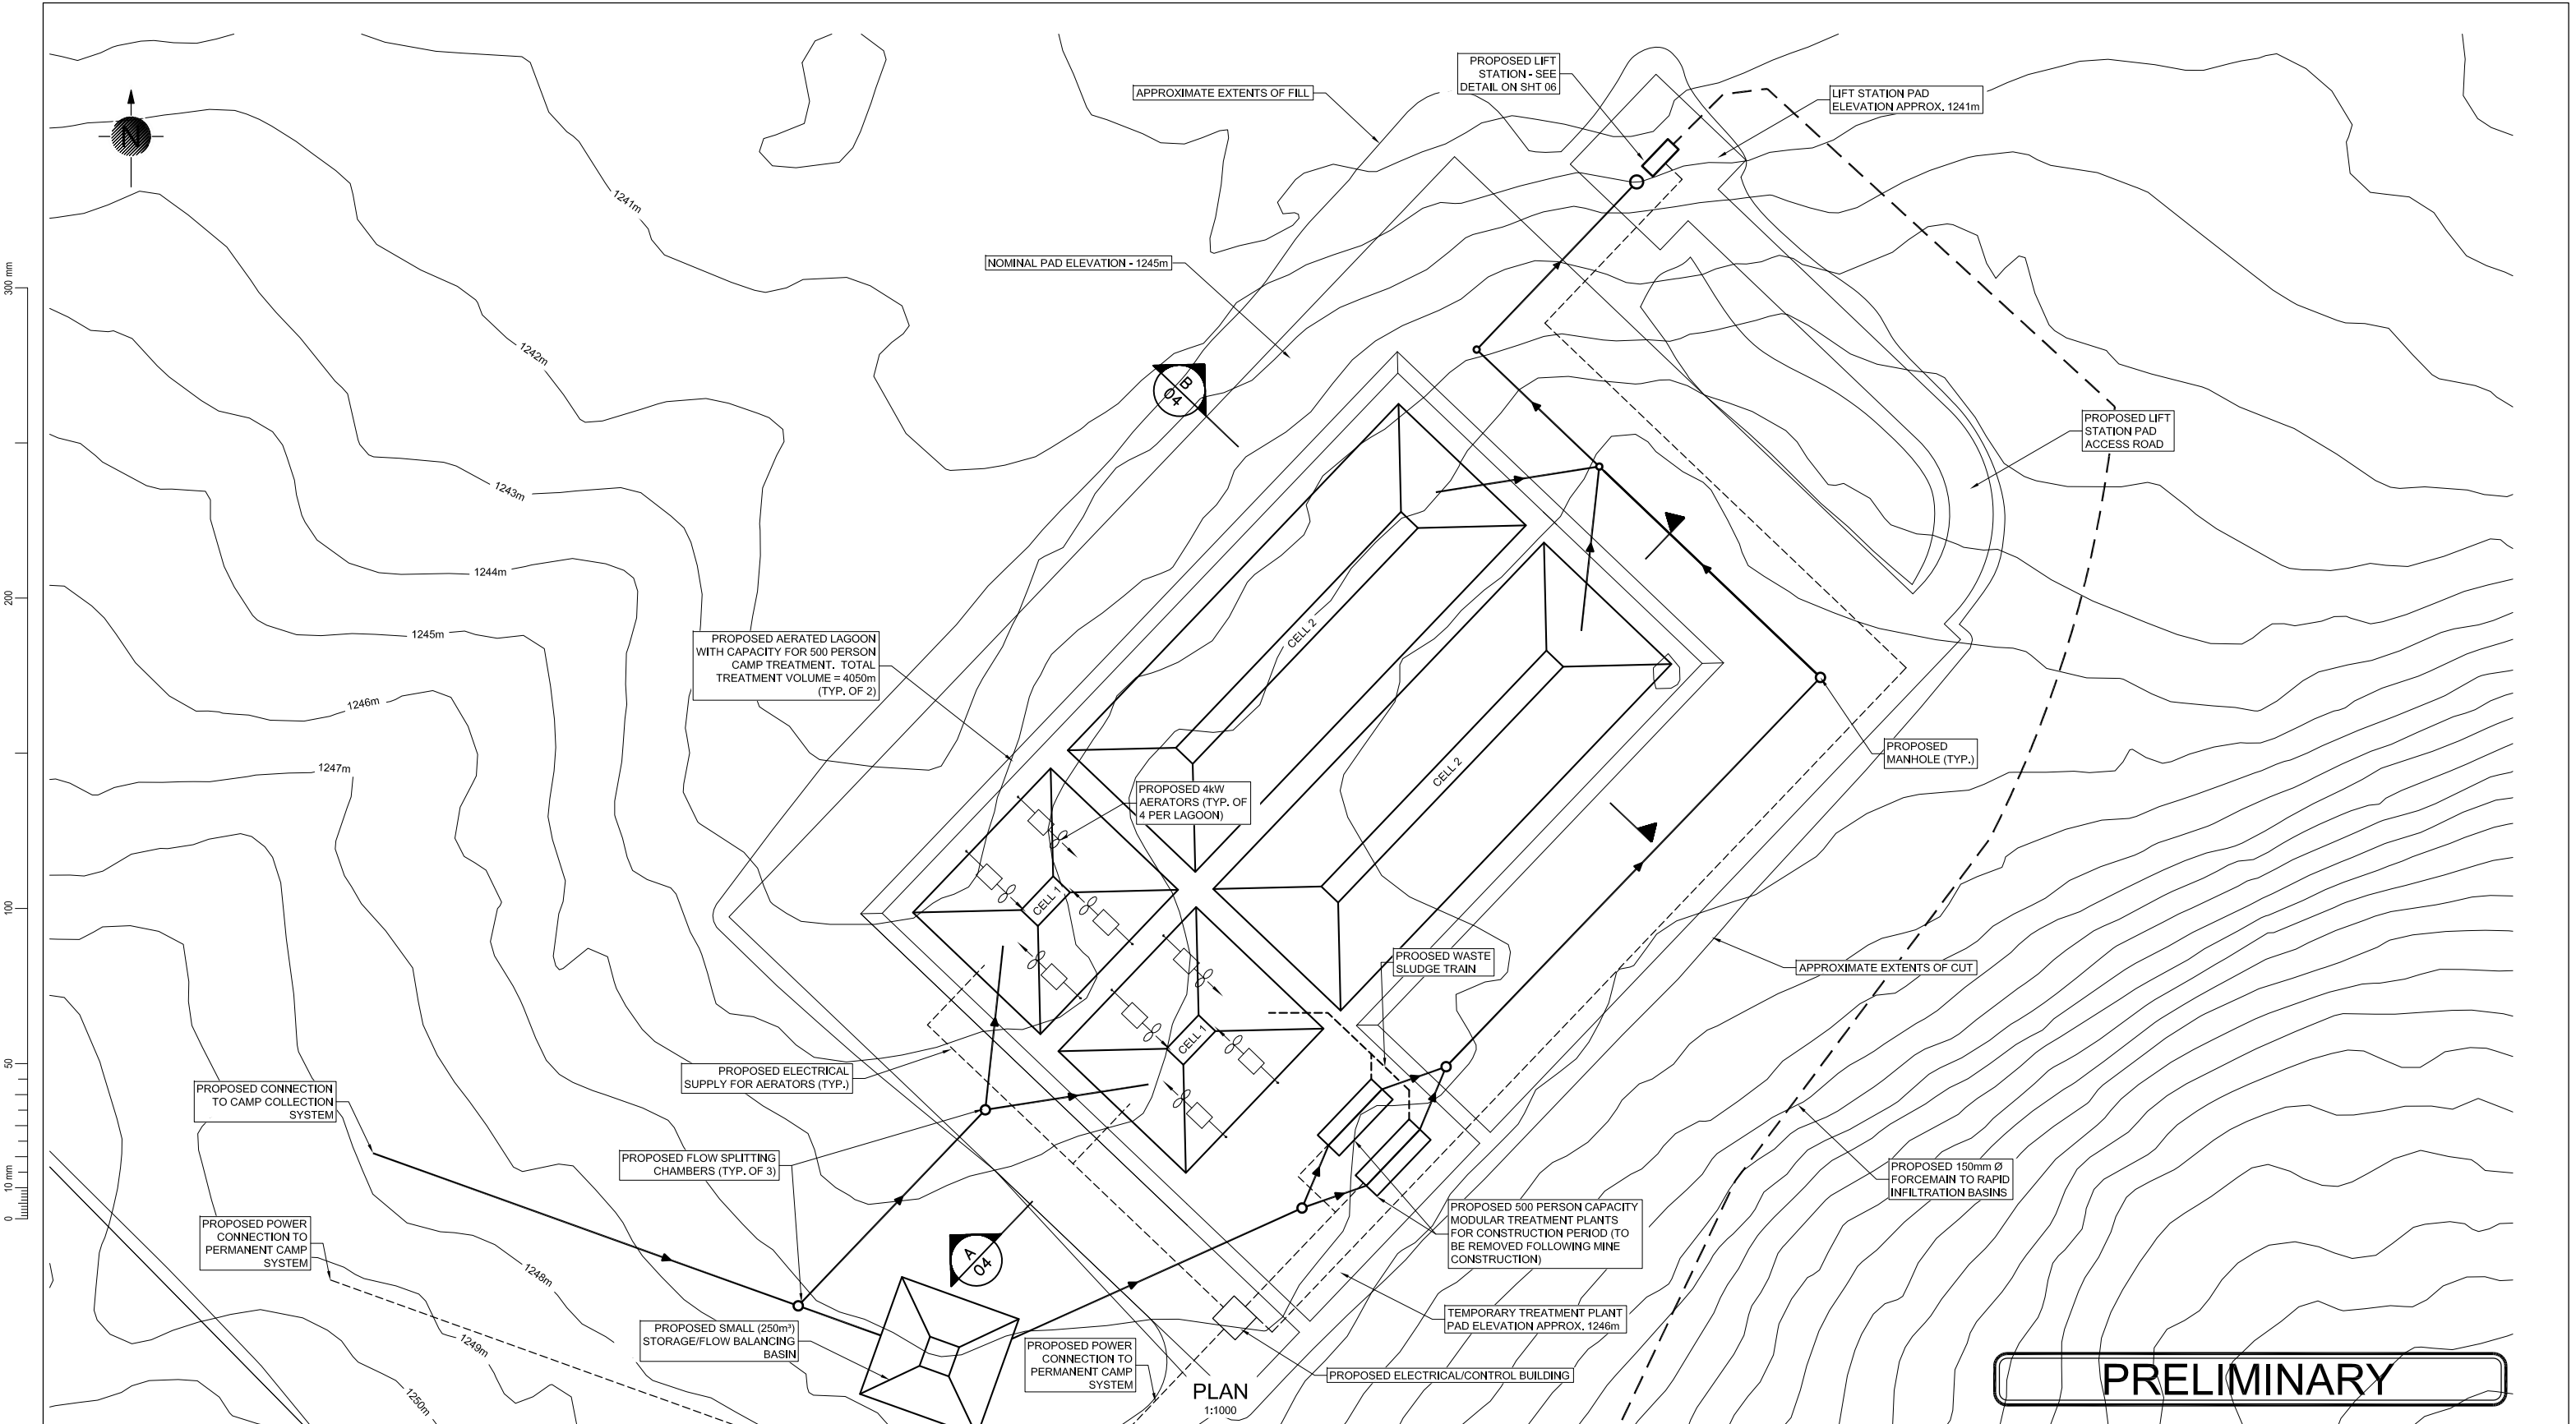

PRELIMINARY

PLAN
1:1000

| Revision | Amendment | Approved | Revision Date |
|----------|--------------------|----------|---------------|
| 1 | PRELIMINARY DESIGN | SRB | SEPT 2013 |
| | | | |
| | | | |
| | | | |
| | | | |
| | | | |

OPUS DAYTONKNIGHT
 Prince George Office
 201 - 1110 6TH AVENUE
 Prince George, BC
 V2L 3M6 CANADA +1 250 5620038



Project
**NEW GOLD INC.
 BLACKWATER PROJECT
 TEMPORARY AND PERMANENT CAMP WASTEWATER SYSTEM**


| Drawn | Designed | Approved | Revision Date |
|-------|----------|----------|---------------|
| LDHB | SRB | SRB | SEPT 2013 |

Sheet
TREATMENT PLANT AND LAGOON SITE PLAN


Project No. D-95002.00 Scale AS SHOWN

Drawing No. PG D-95002.00 Sheet No. 03 Revision 1

1:1
 0 10 20 30 40 50 60 70 80 90 100 mm

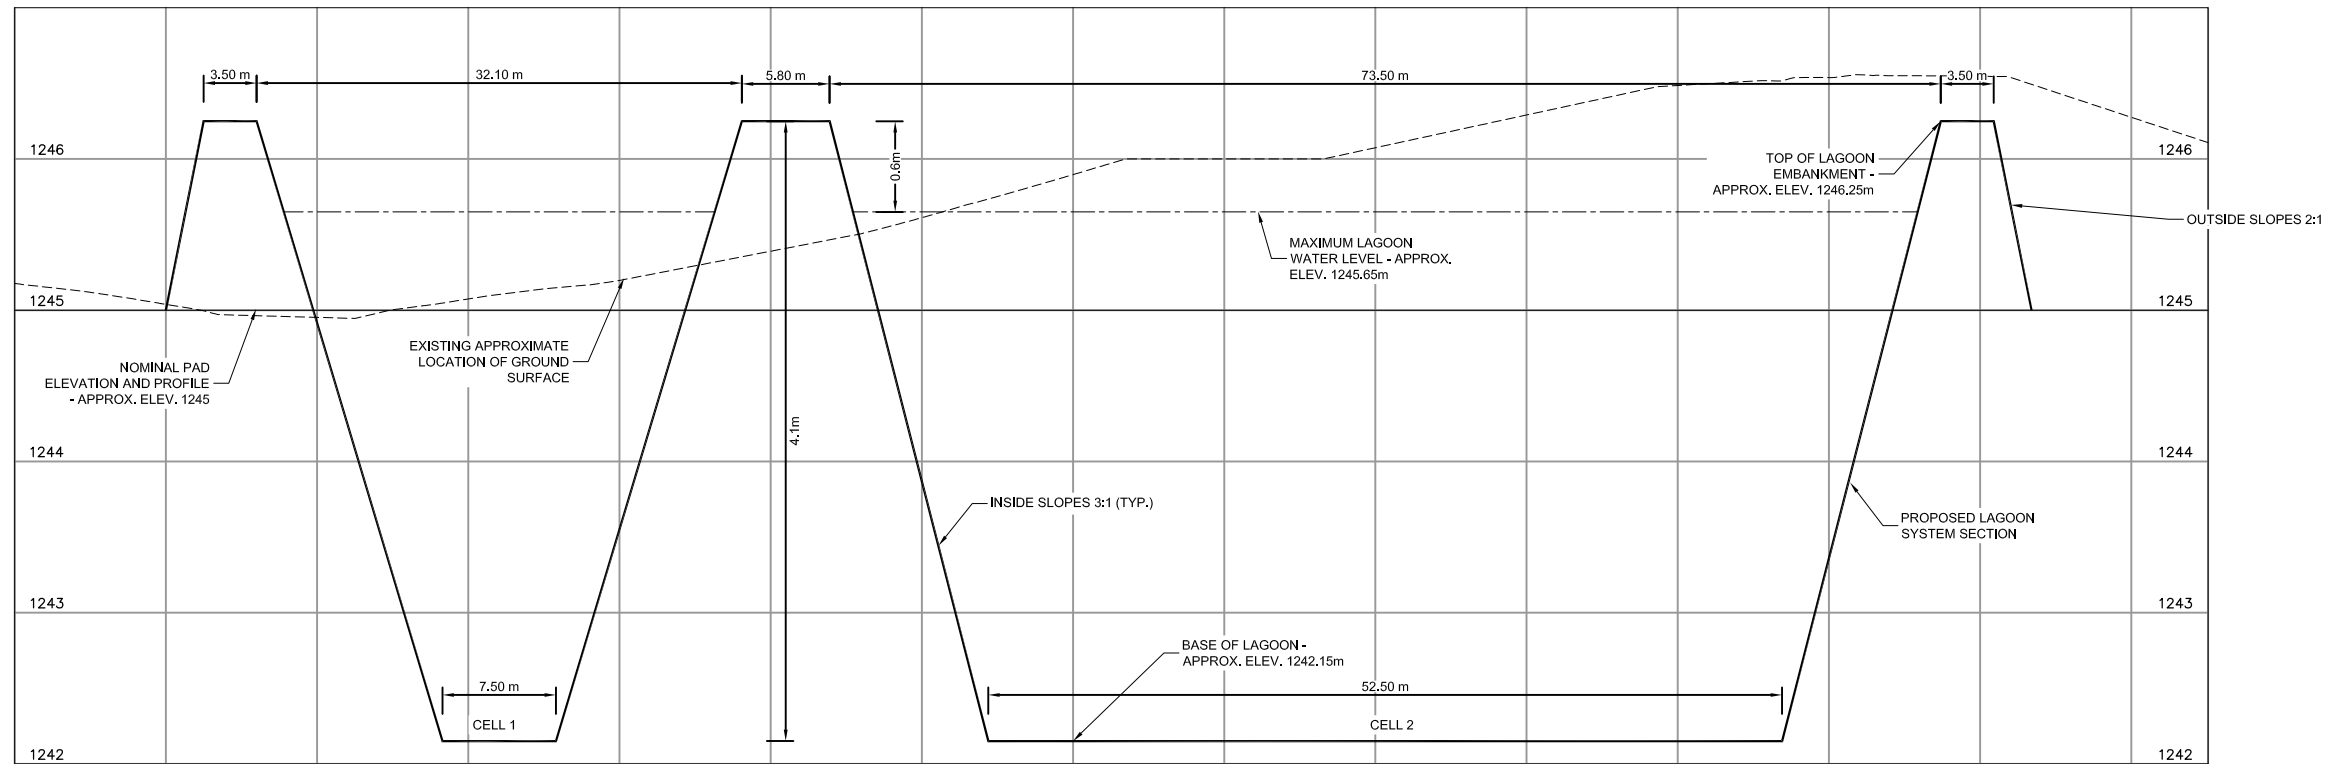

SECTION **A**
1:500 **03**

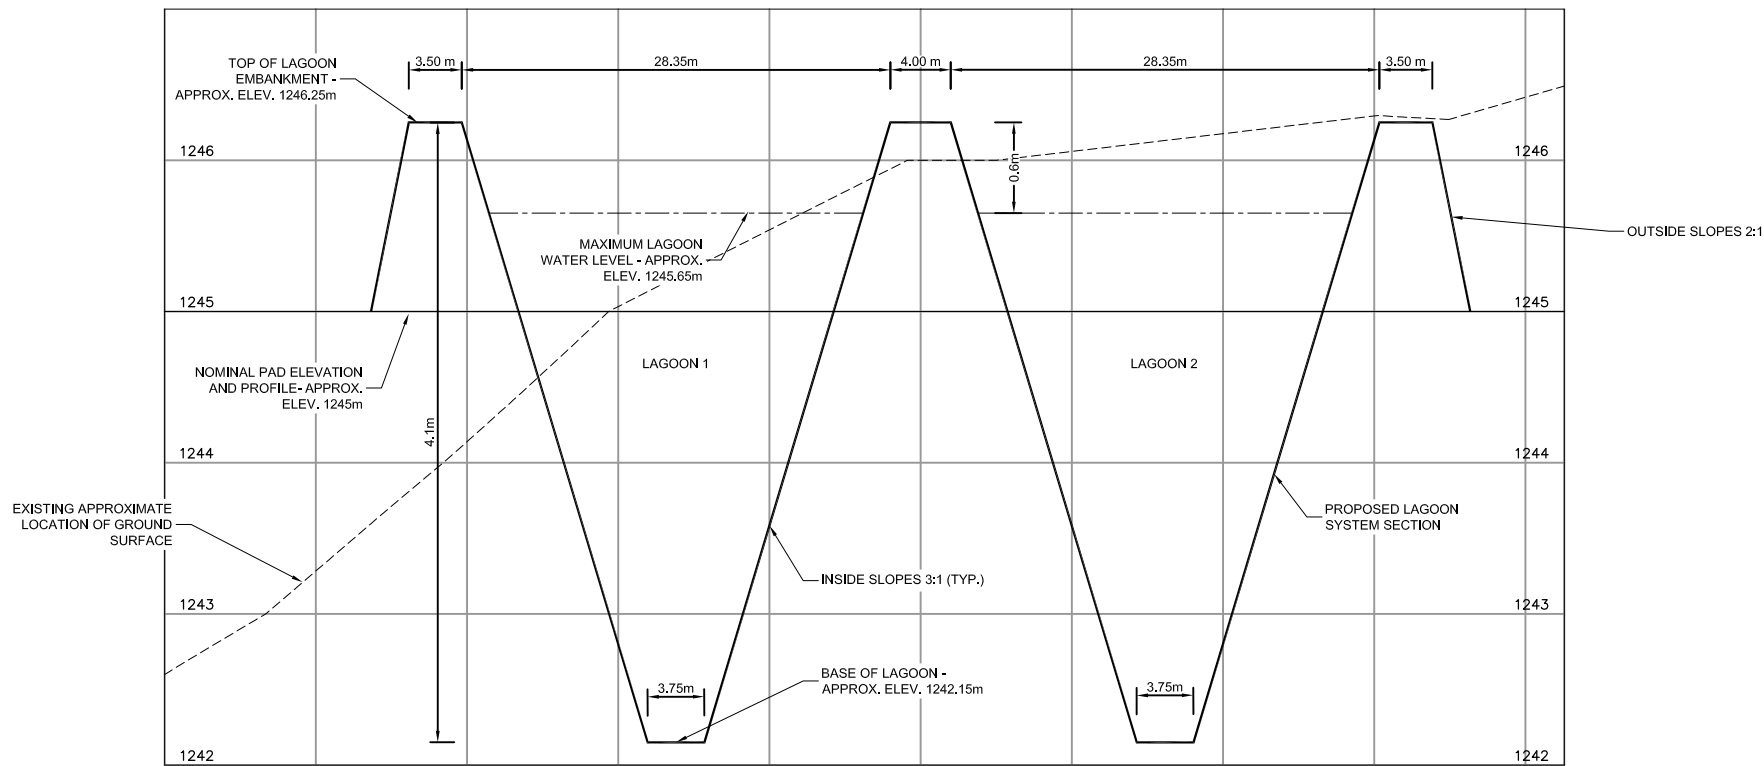

SECTION **B**
1:500 **03**

PRELIMINARY

| Revision | Amendment | Approved | Revision Date |
|----------|--------------------|----------|---------------|
| 1 | PRELIMINARY DESIGN | SRB | SEPT 2013 |
| | | | |
| | | | |
| | | | |
| | | | |
| | | | |
| | | | |
| | | | |
| | | | |

OPUS DAYTONKNIGHT
 Prince George Office
 201 - 1110 6TH AVENUE
 Prince George, BC
 V2L 3M6 CANADA +1 250 5620038

Drawn: LDHB, Designed: SRB, Approved: SRB, Revision Date: SEPT 2013

 
Project No.: D-95002.00, Scale: AS SHOWN


Project: NEW GOLD INC. BLACKWATER PROJECT TEMPORARY AND PERMANENT CAMP WASTEWATER SYSTEM

Sheet: LAGOON SECTIONS


Drawing No.: PG D-95002.00, Sheet No.: 04, Revision: 1

300 mm
200
100
50
10 mm
0



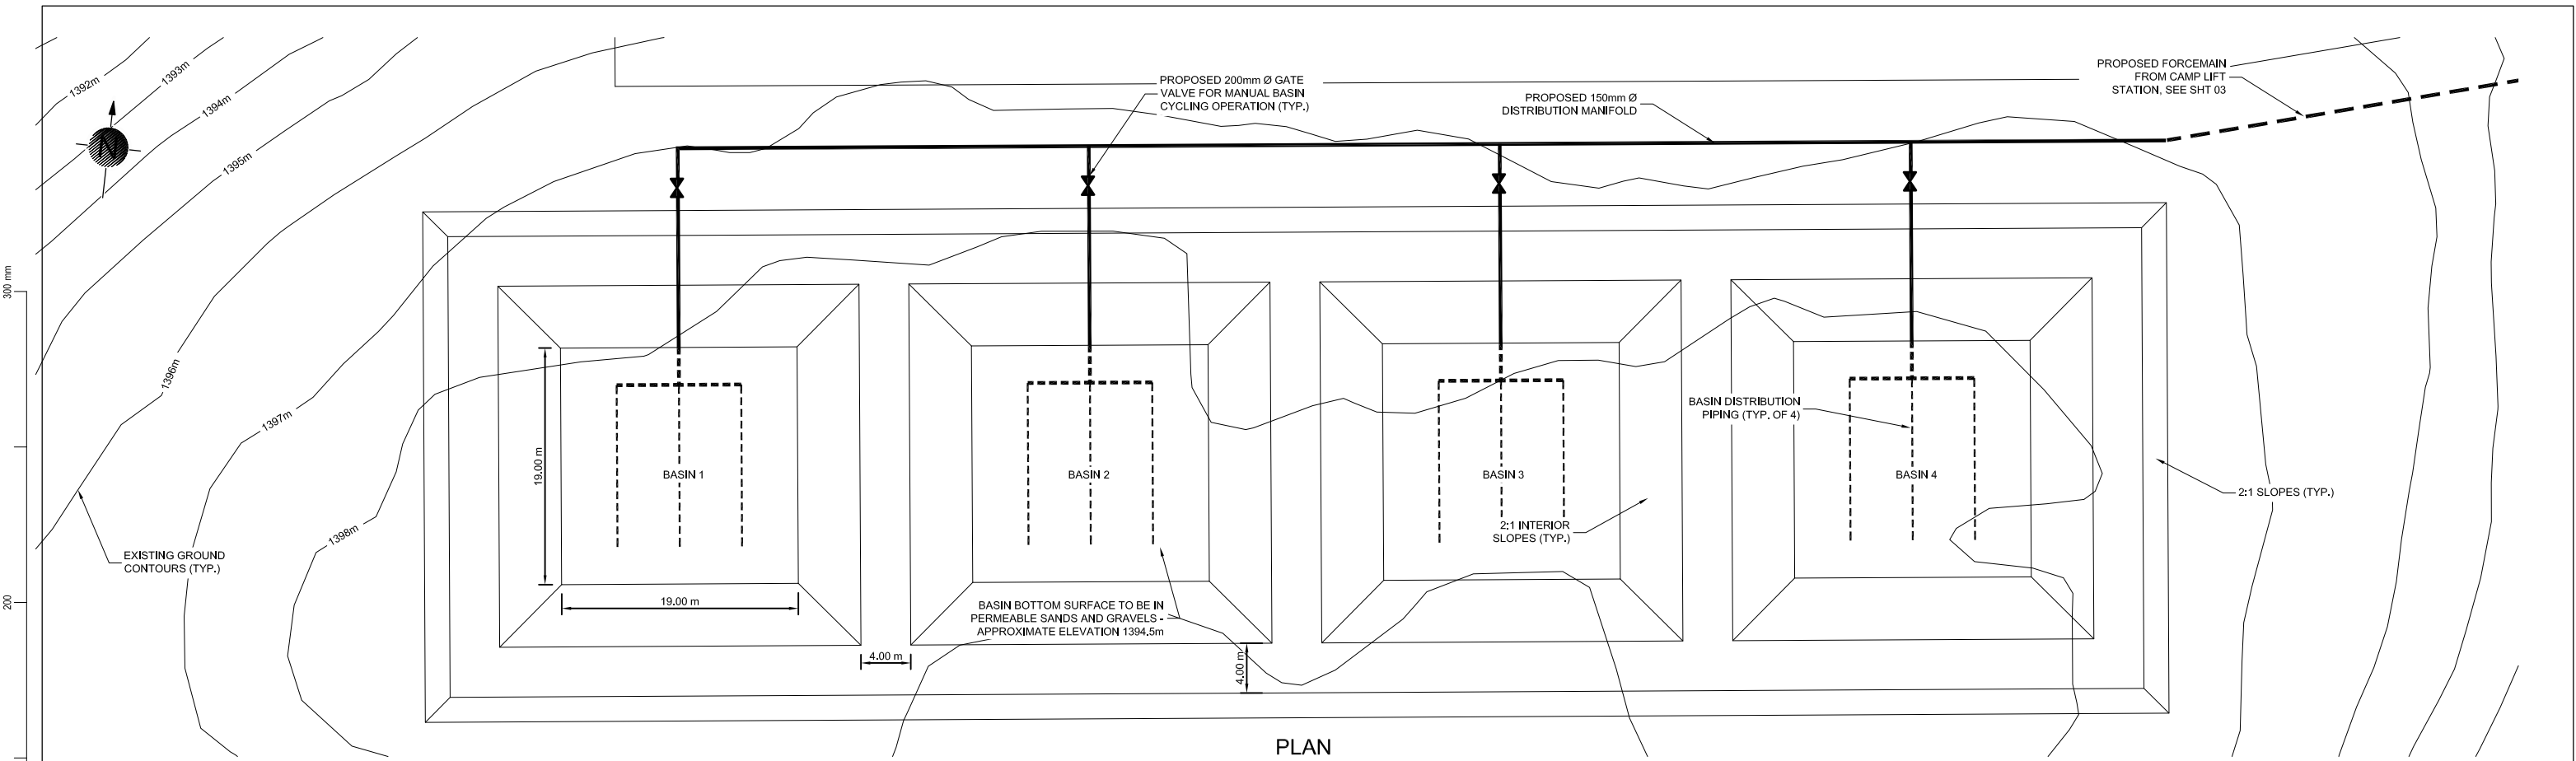

PLAN
1:500

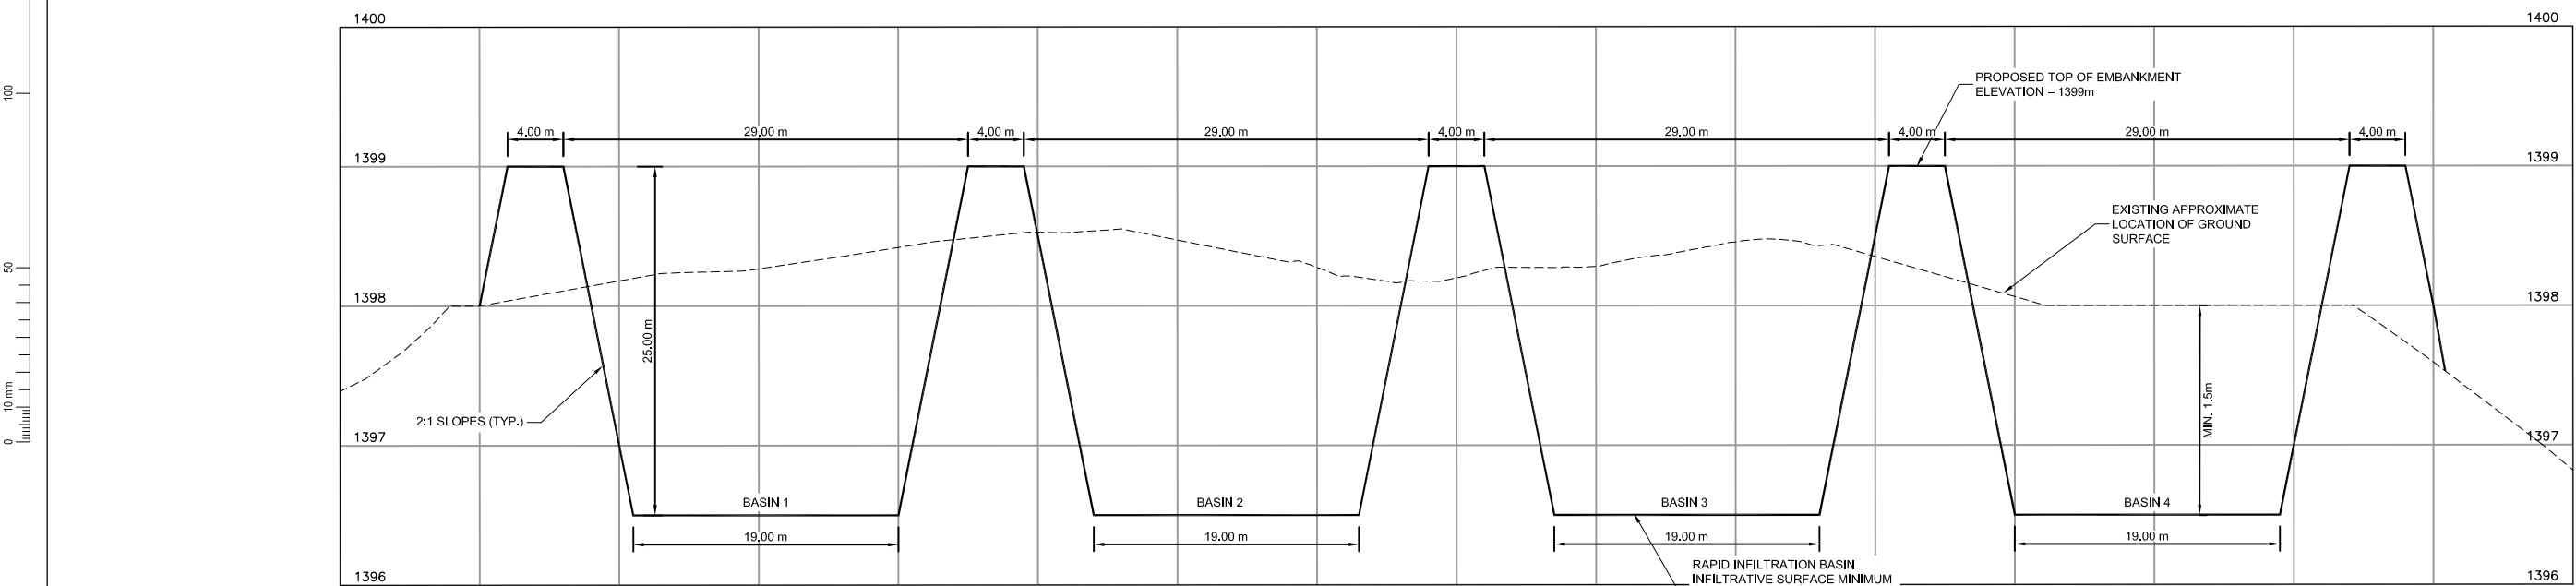

PROFILE
HORZ: 1:500 VERT: 1:50

PRELIMINARY

| Revision | Amendment | Approved | Revision Date |
|----------|--------------------|----------|---------------|
| 1 | PRELIMINARY DESIGN | SRB | SEPT 2013 |
| | | | |
| | | | |
OPUS DAYTONKNIGHT
 Prince George Office
 201 - 1110 6TH AVENUE
 Prince George, BC
 V2L 3M6 CANADA +1 250 5620038



 
Project
 NEW GOLD INC.
 BLACKWATER PROJECT
 TEMPORARY AND PERMANENT CAMP WASTEWATER SYSTEM


Drawn: LDHB, Designed: SRB, Approved: SRB, Revision Date: SEPT 2013

Sheet
**RAPID INFILTRATION BASIN
 PLAN AND PROFILE**


Project No.: D-95002.00, Scale: AS SHOWN

Drawing No.: PG D-95002.00, Sheet No.: 05, Revision: 1



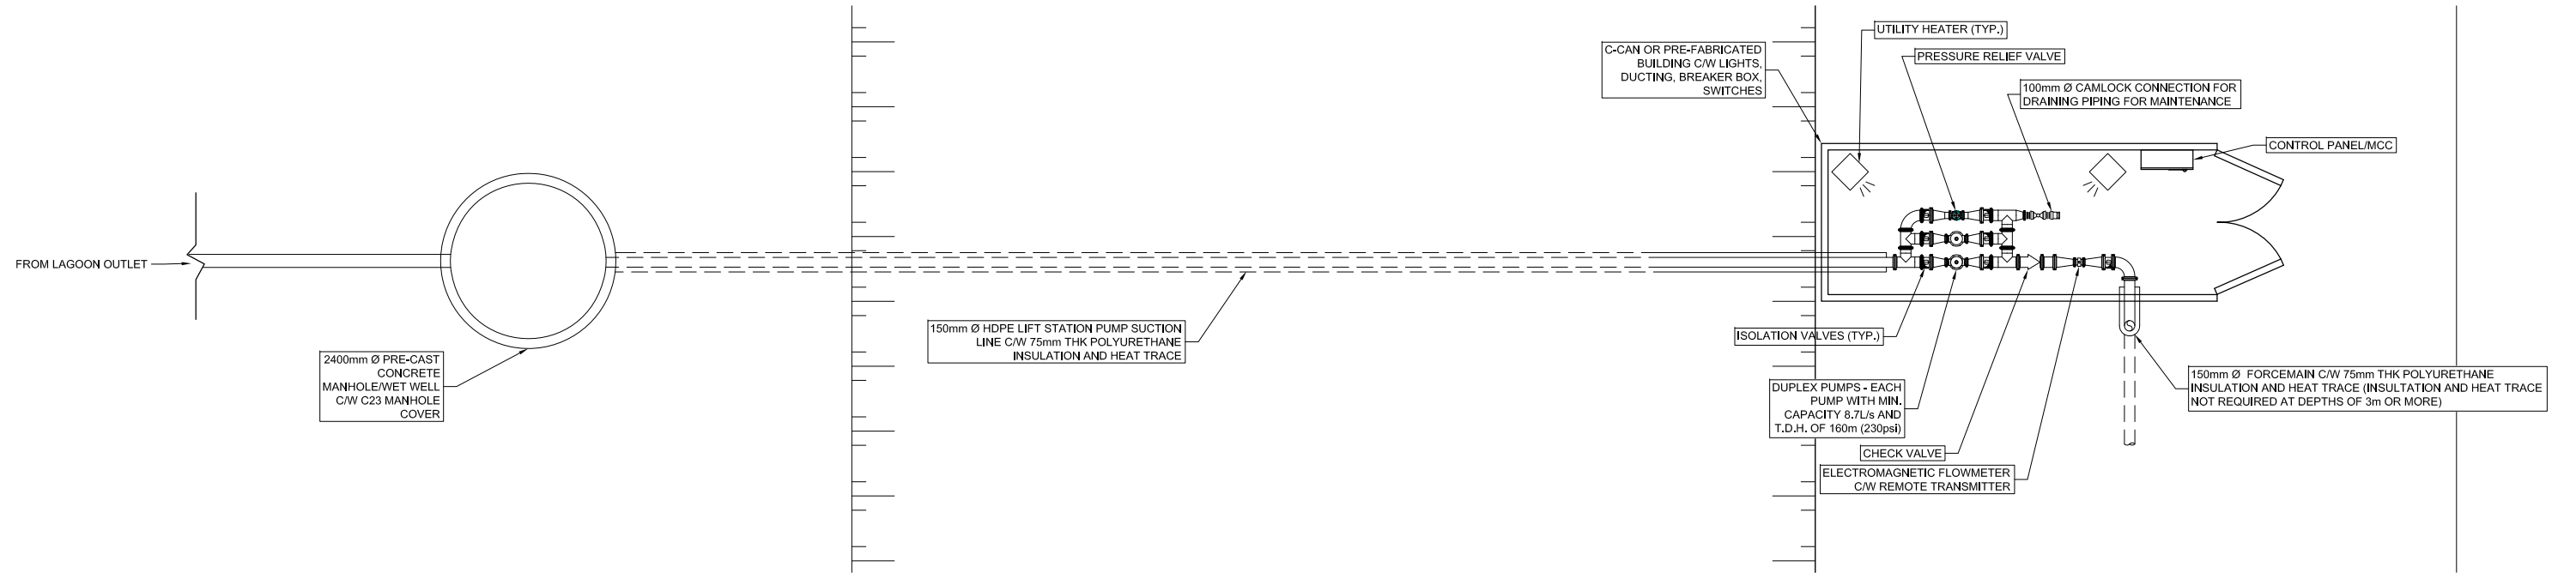

PLAN
SCALE: 1:25

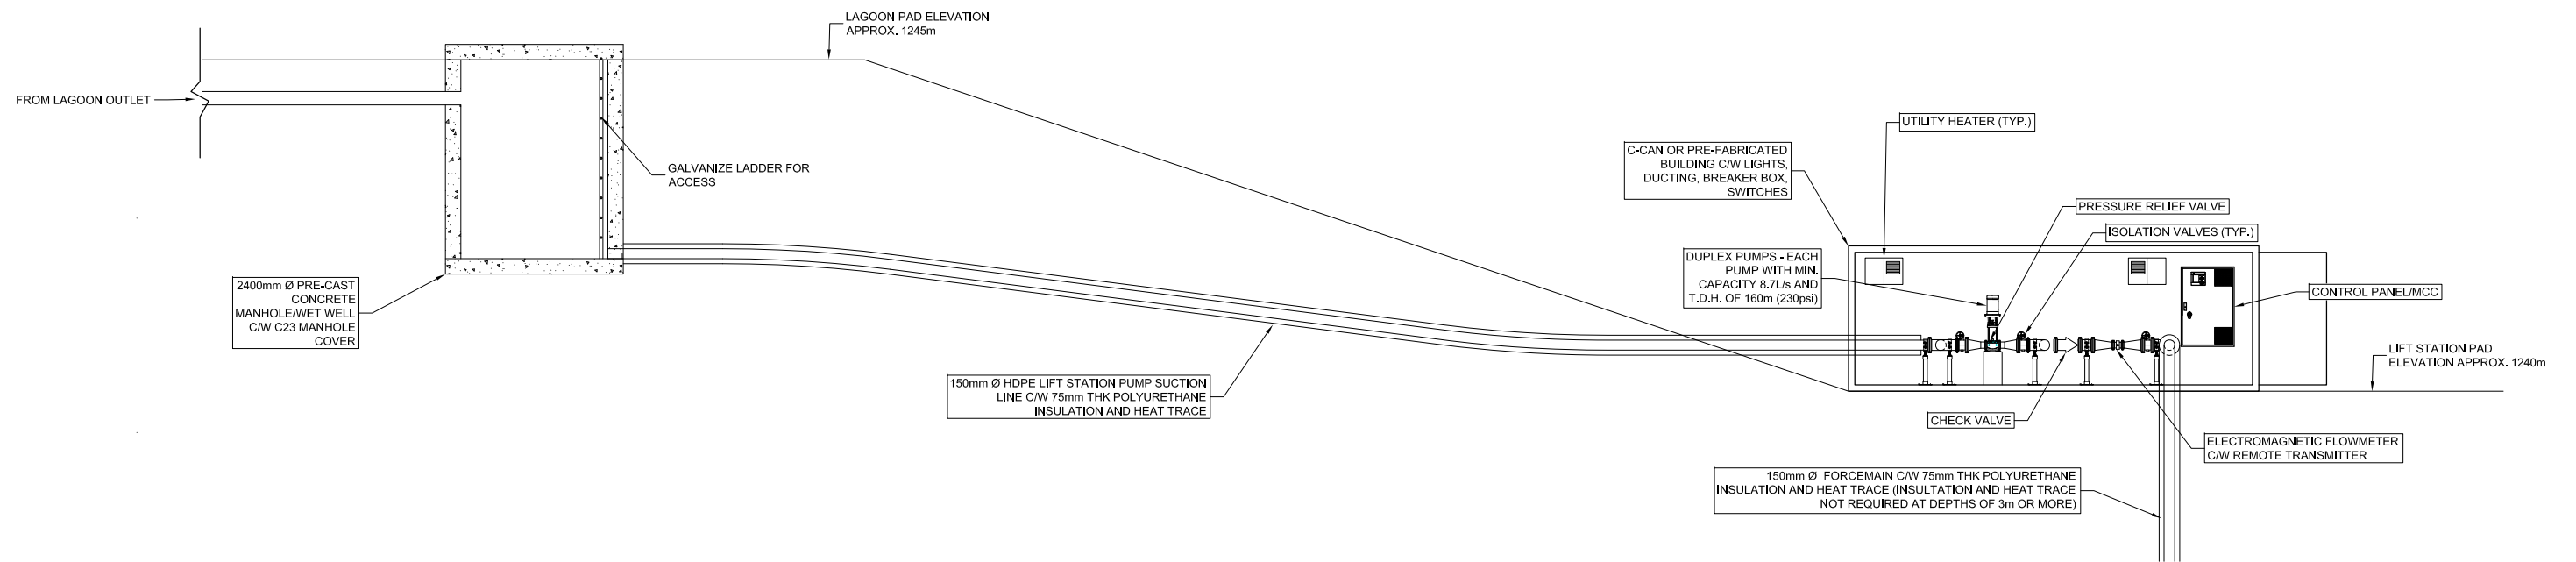

PROFILE
SCALE: 1:25

PRELIMINARY

| Revision | Amendment | Approved | Revision Date |
|----------|--------------------|----------|---------------|
| 1 | PRELIMINARY DESIGN | SRB | SEPT 2013 |
| | | | |
| | | | |
| | | | |
| | | | |
| | | | |

OPUS DAYTONKNIGHT
 Prince George Office
 201 - 1110 6TH AVENUE
 Prince George, BC
 V2L 3M6 CANADA +1 250 5620038



Project
 NEW GOLD INC.
 BLACKWATER PROJECT
 TEMPORARY AND PERMANENT CAMP WASTEWATER SYSTEM

| Drawn | Designed | Approved | Revision Date |
|-------|----------|----------|---------------|
| LDHB | SRB | SRB | SEPT 2013 |

Sheet
**EFFLUENT LIFT STATION
 GENERAL ARRANGEMENT**

| Project No. | Scale | Drawing No. | Sheet No. | Revision |
|-------------|----------|---------------|-----------|----------|
| D-95002.00 | AS SHOWN | PG D-95002.00 | 06 | 1 |